


NOTE

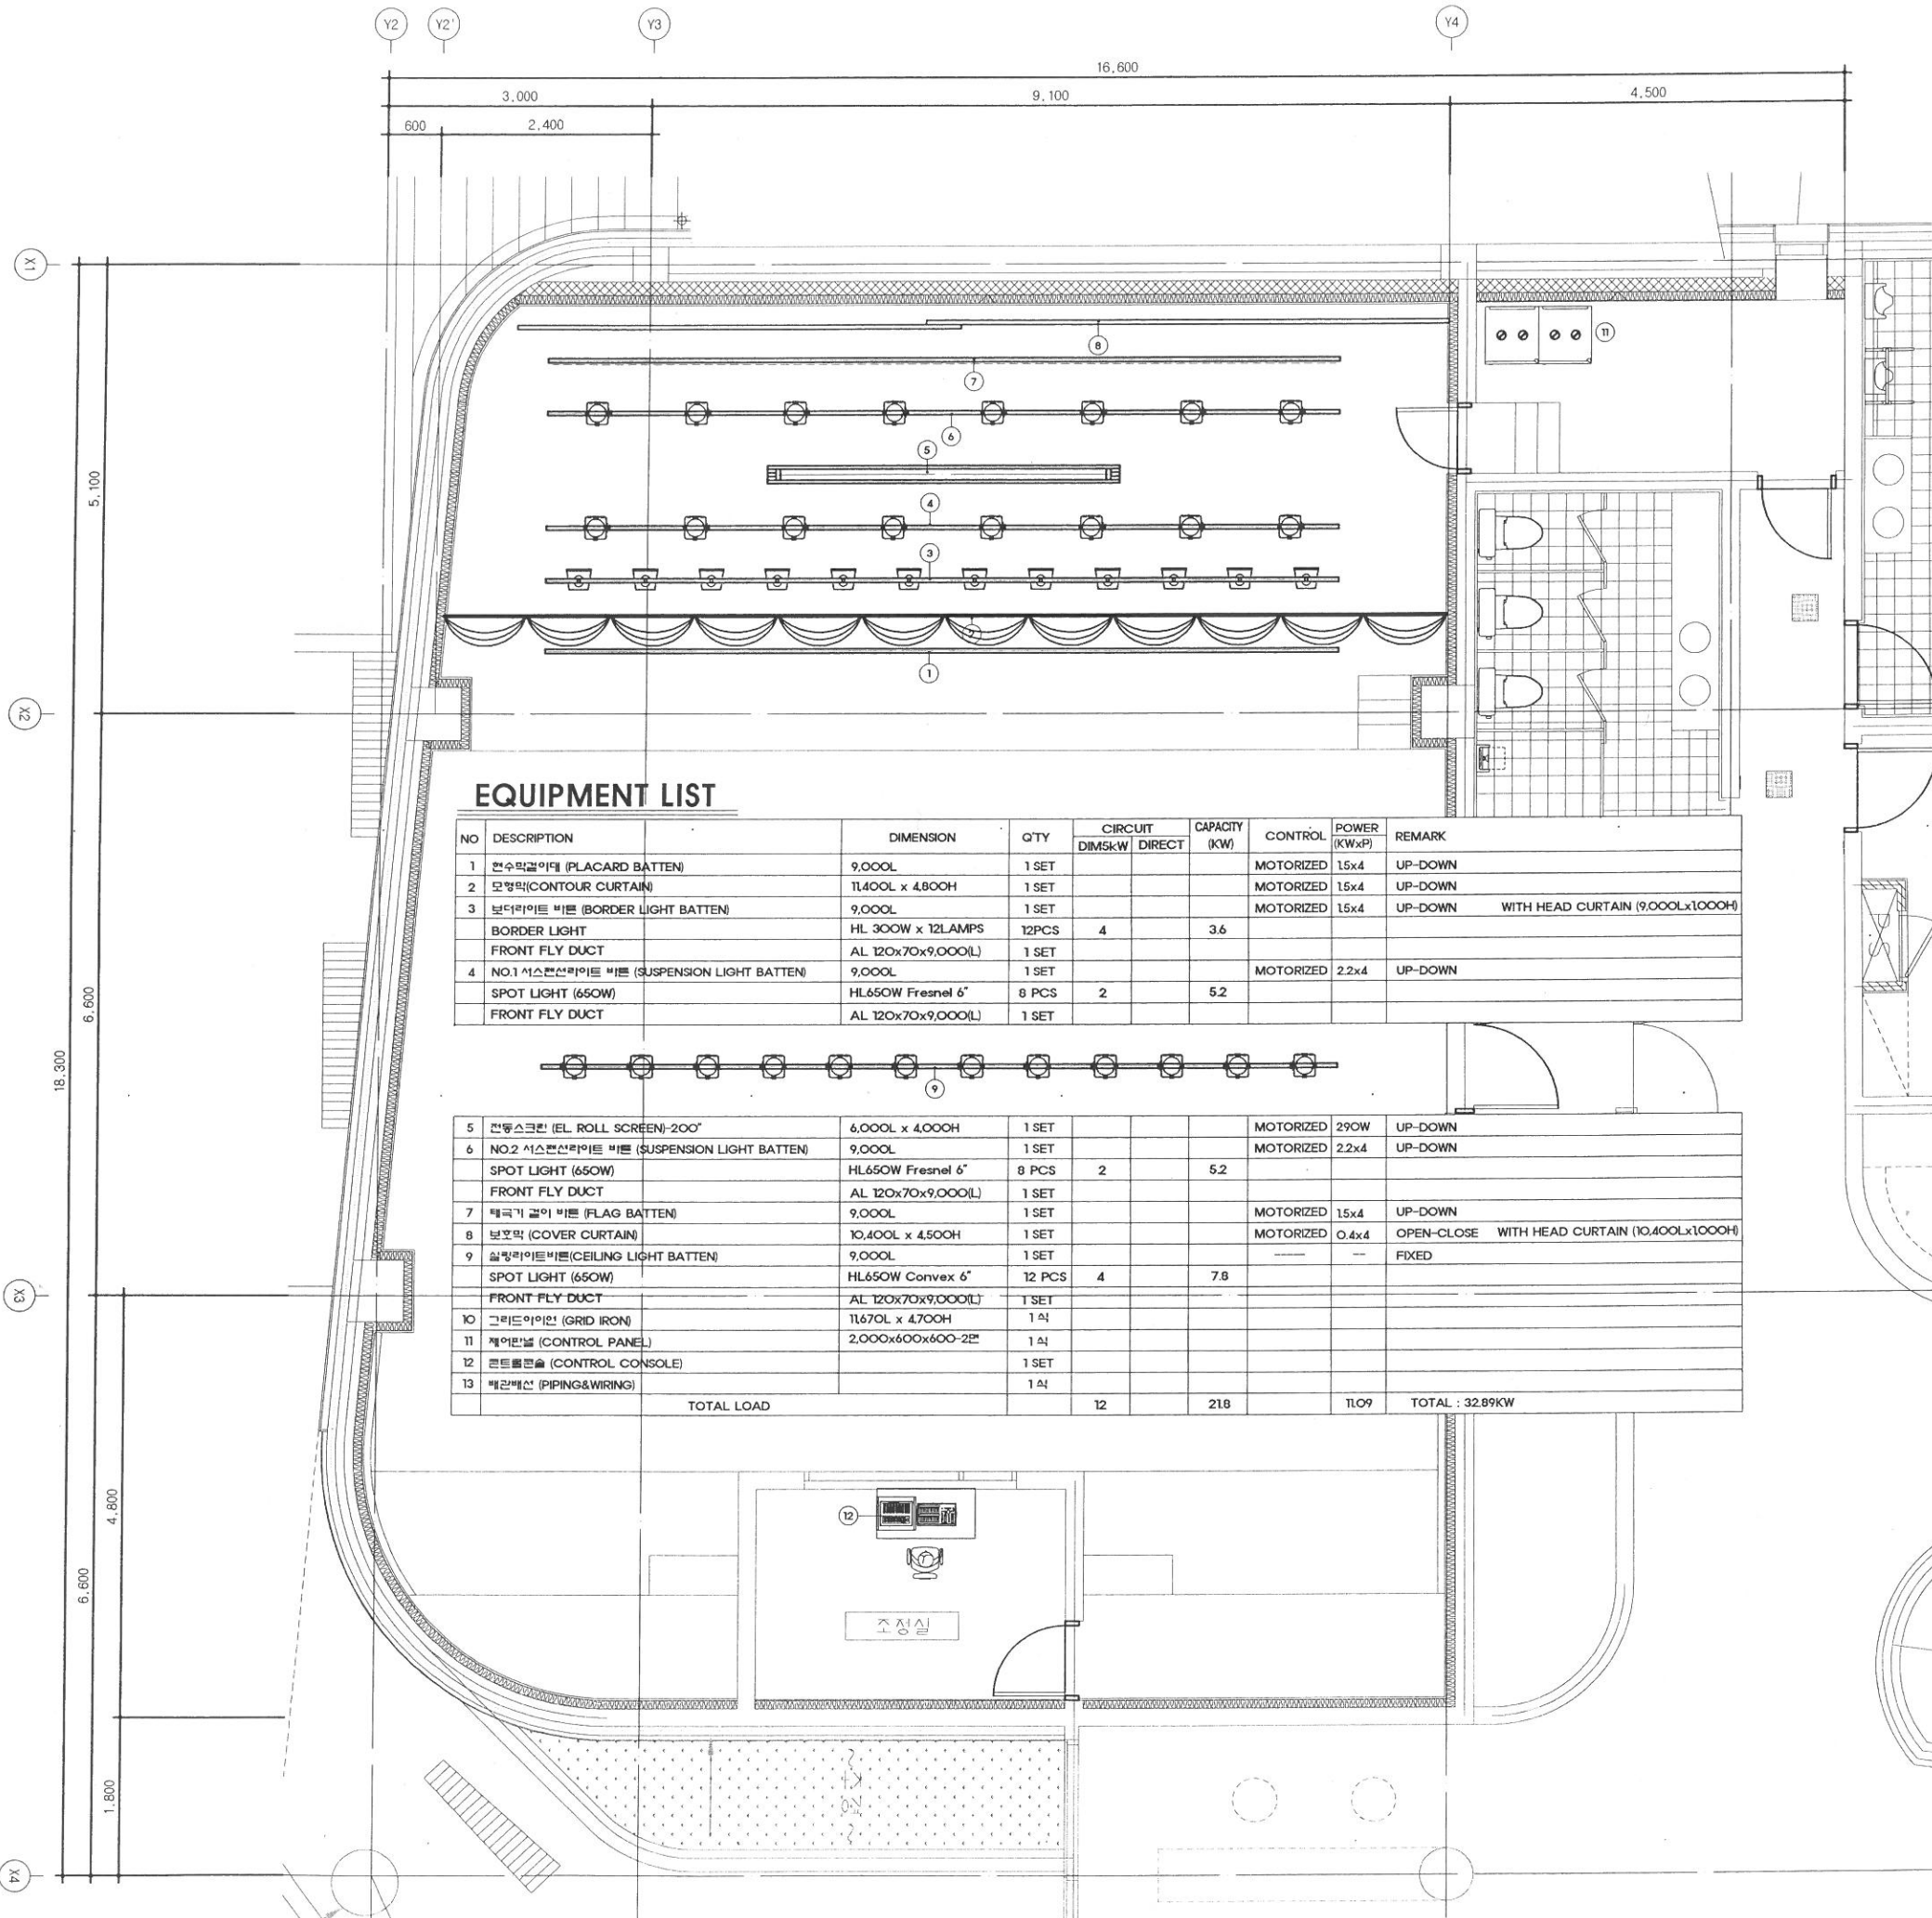

EQUIPMENT LIST

NO	DESCRIPTION	DIMENSION	QTY	CIRCUIT		CAPACITY (KW)	CONTROL	POWER (KWxP)	REMARK
				DIMSxW	DIRECT				
1	현수막걸이대 (PLACARD BATTEN)	9,000L	1 SET				MOTORIZED	15x4	UP-DOWN
2	모양막(CONTOUR CURTAIN)	11,400L x 4,800H	1 SET				MOTORIZED	15x4	UP-DOWN
3	보더라이트 바튼 (BORDER LIGHT BATTEN)	9,000L	1 SET				MOTORIZED	15x4	UP-DOWN WITH HEAD CURTAIN (9,000Lx1,000H)
	BORDER LIGHT	HL 300W x 12LAMPS	12PCS	4		3.6			
4	FRONT FLY DUCT	AL 120x70x9,000(L)	1 SET						
4	NO.1 서스펜션라이트 바튼 (SUSPENSION LIGHT BATTEN)	9,000L	1 SET				MOTORIZED	2.2x4	UP-DOWN
	SPOT LIGHT (650W)	HL650W Fresnel 6"	8 PCS	2		5.2			
	FRONT FLY DUCT	AL 120x70x9,000(L)	1 SET						
5	전동스크린 (EL. ROLL SCREEN)-200"	6,000L x 4,000H	1 SET				MOTORIZED	290W	UP-DOWN
6	NO.2 서스펜션라이트 바튼 (SUSPENSION LIGHT BATTEN)	9,000L	1 SET				MOTORIZED	2.2x4	UP-DOWN
	SPOT LIGHT (650W)	HL650W Fresnel 6"	8 PCS	2		5.2			
	FRONT FLY DUCT	AL 120x70x9,000(L)	1 SET						
7	배극기 걸이 바튼 (FLAG BATTEN)	9,000L	1 SET				MOTORIZED	15x4	UP-DOWN
8	보호막 (COVER CURTAIN)	10,400L x 4,500H	1 SET				MOTORIZED	0.4x4	OPEN-CLOSE WITH HEAD CURTAIN (10,400Lx1,000H)
9	실링라이트바튼(CEILING LIGHT BATTEN)	9,000L	1 SET						FIXED
	SPOT LIGHT (650W)	HL650W Convex 6"	12 PCS	4		7.8			
	FRONT FLY DUCT	AL 120x70x9,000(L)	1 SET						
10	그리드아이언 (GRID IRON)	11,670L x 4,700H	1식						
11	제어판넬 (CONTROL PANEL)	2,000x600x600-2면	1식						
12	콘트롤콘솔 (CONTROL CONSOLE)		1 SET						
13	배관배선 (PIPING&WIRING)		1식						
TOTAL LOAD				12		218		1109	TOTAL : 32.89KW

△		
△		
△		
△		
△		

NO.	DATE	DESCRIPTION
-----	------	-------------

ISSUES & REVISIONS

DRAWING TITLE
(도면명)

공연장 확대 평면도

DATE	2015. 09.	SCALE	A3 1/80
			A1 1/40

FILE NAME

APPROVED BY (승인)

CHECKED BY (검사)

DRAWING BY (설계)

SM 공연장 확대 평면도 A3=1/80

SHEET NO. (발판번호) □□□-□□□

DRAWING NO. (도면번호) SM 010-0102